




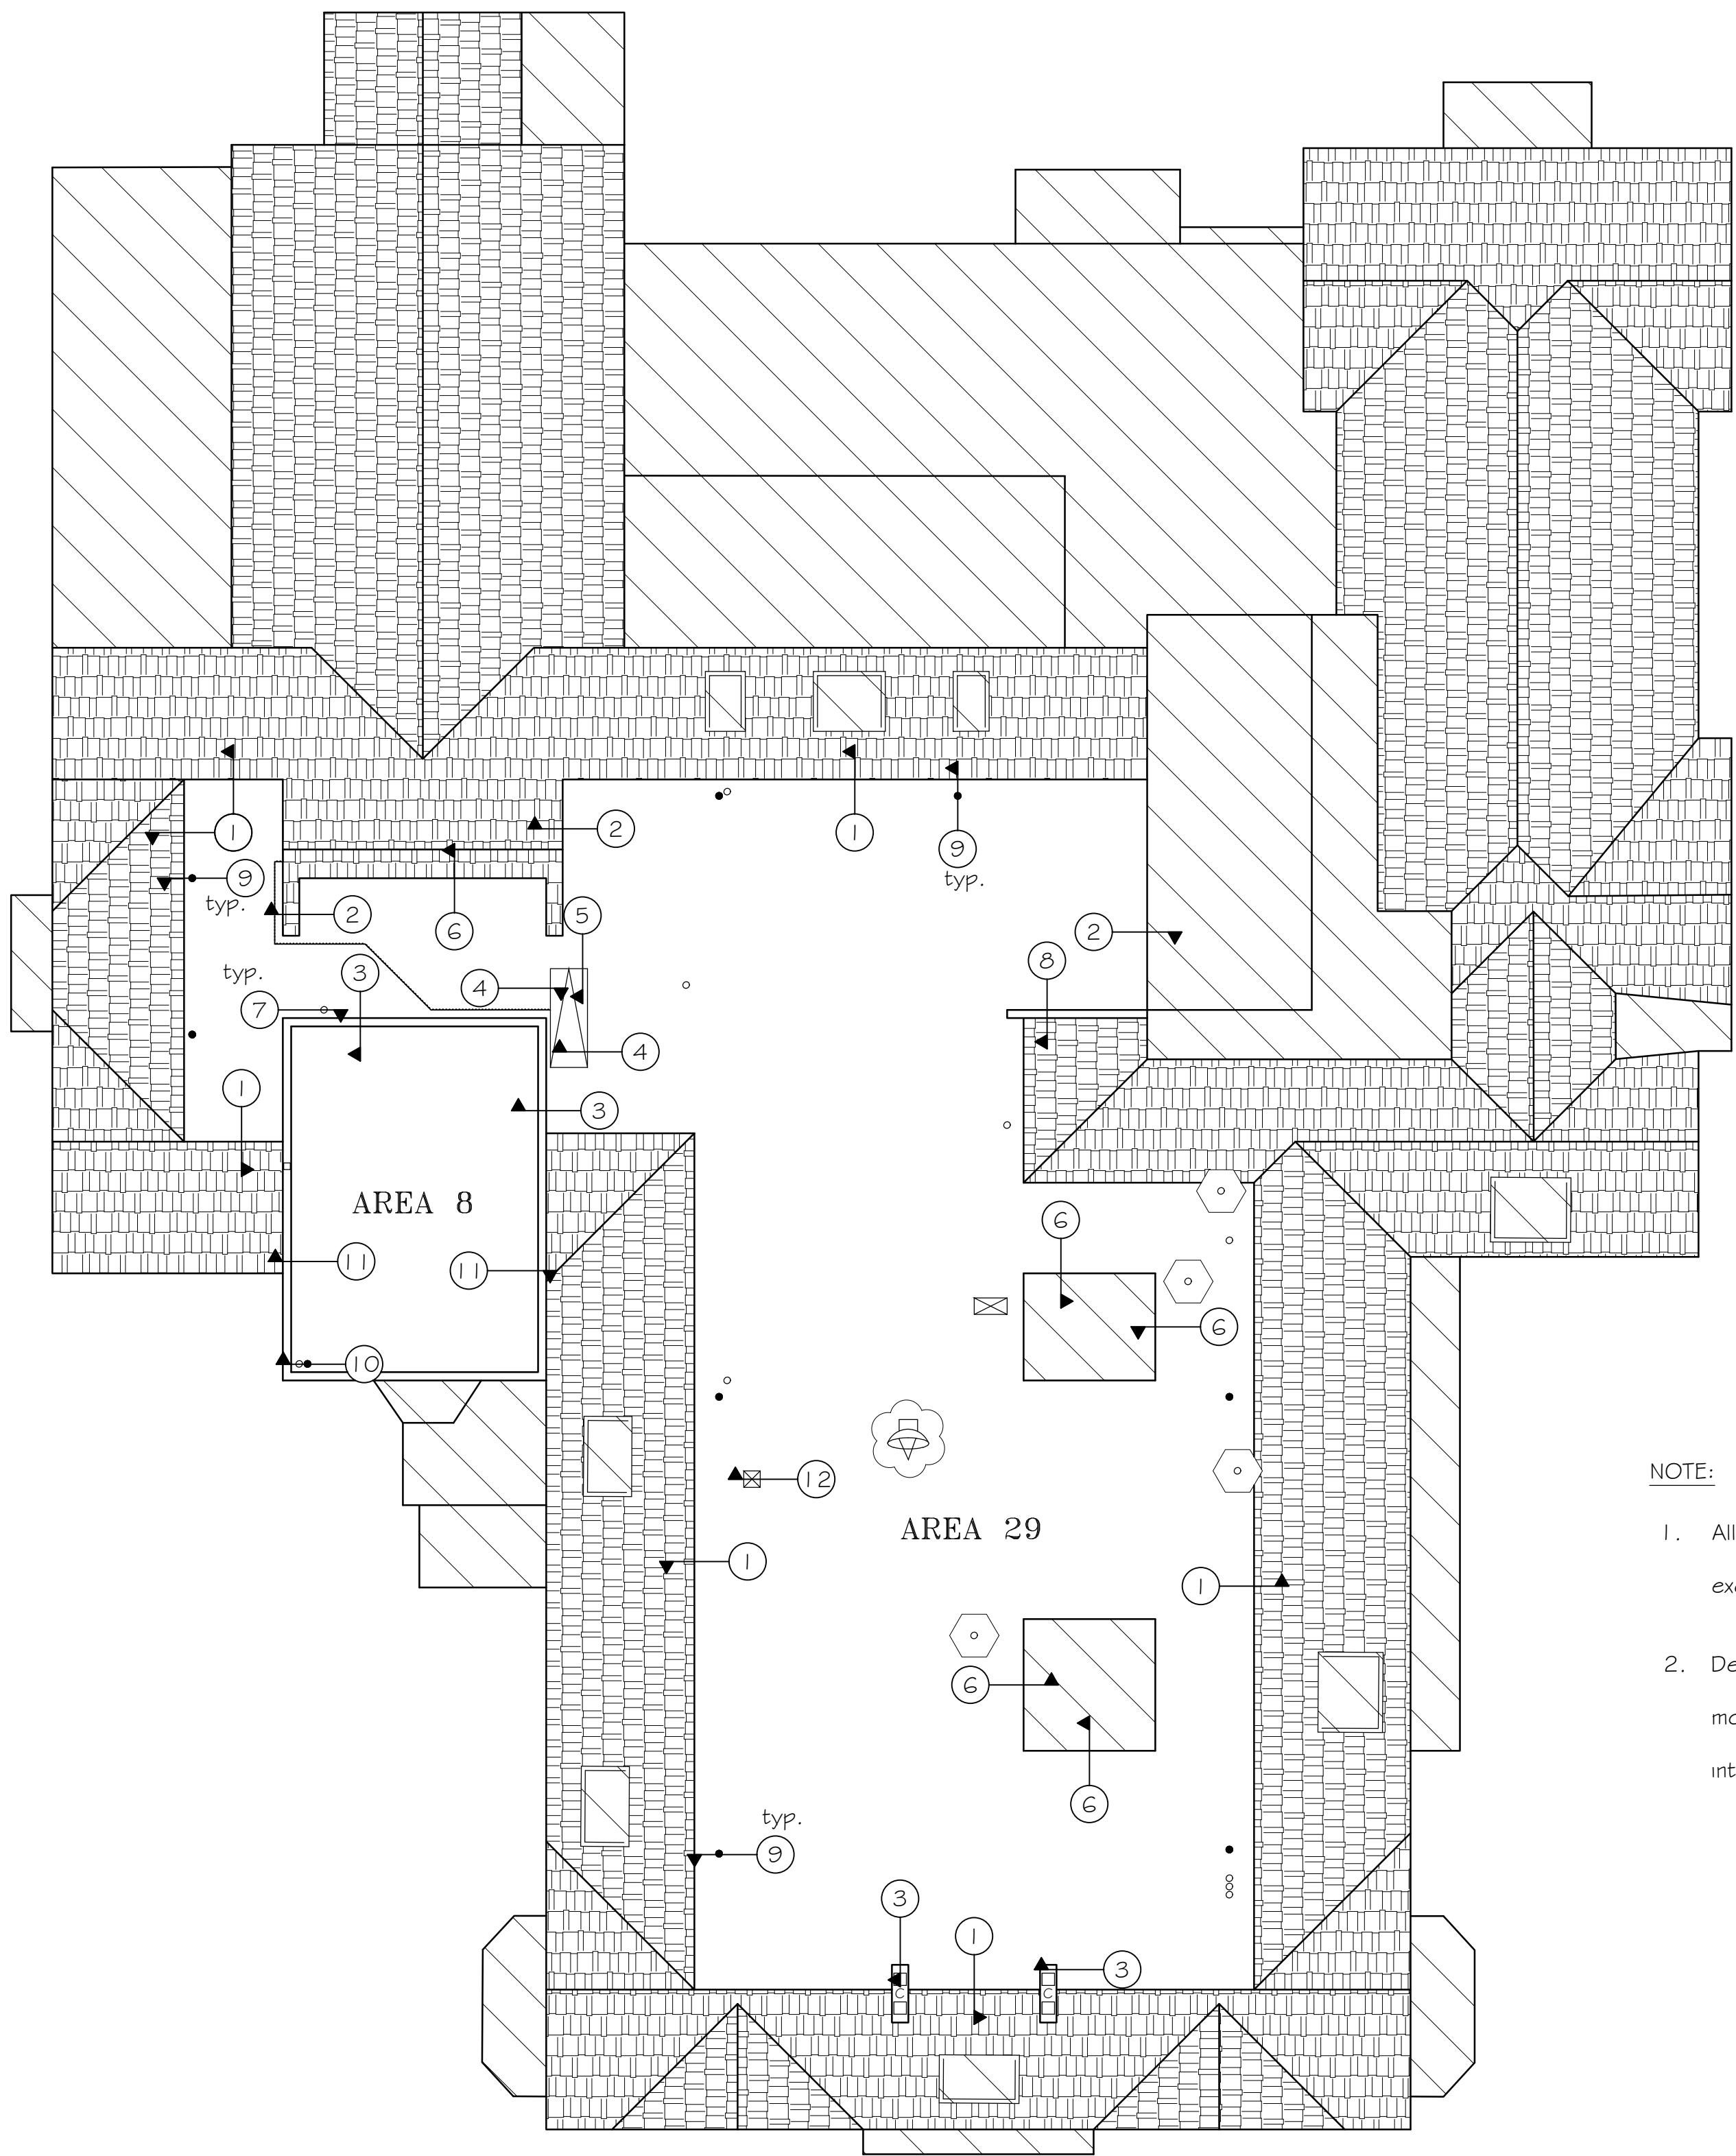



- NOTE:
- All vent pipe extensions are to be removed except where designated on the roof plan:
 - Designated vent pipe extensions are to be modified and terminated 3'-0" above nearest intake vent.

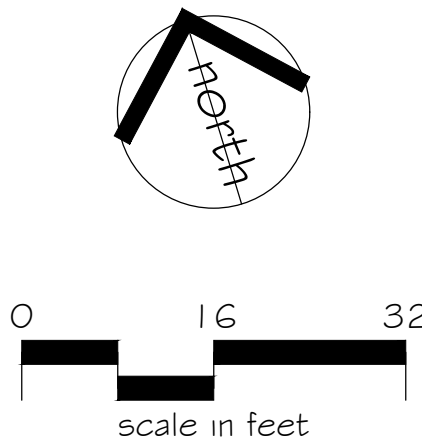

- LEGEND:
- mechanical unit
 - drain
 - round penetration
 - obsolete
 - not in contract
 - concrete pavers
 - RTA detail
 - vent pipe extension to be modified

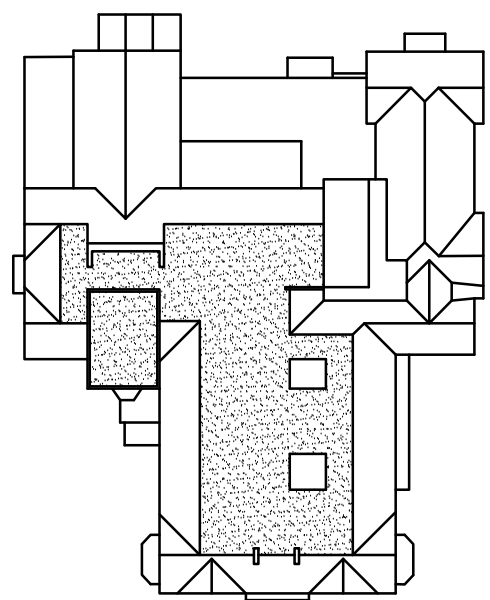

ROOF AREA PLAN
NOT TO SCALE

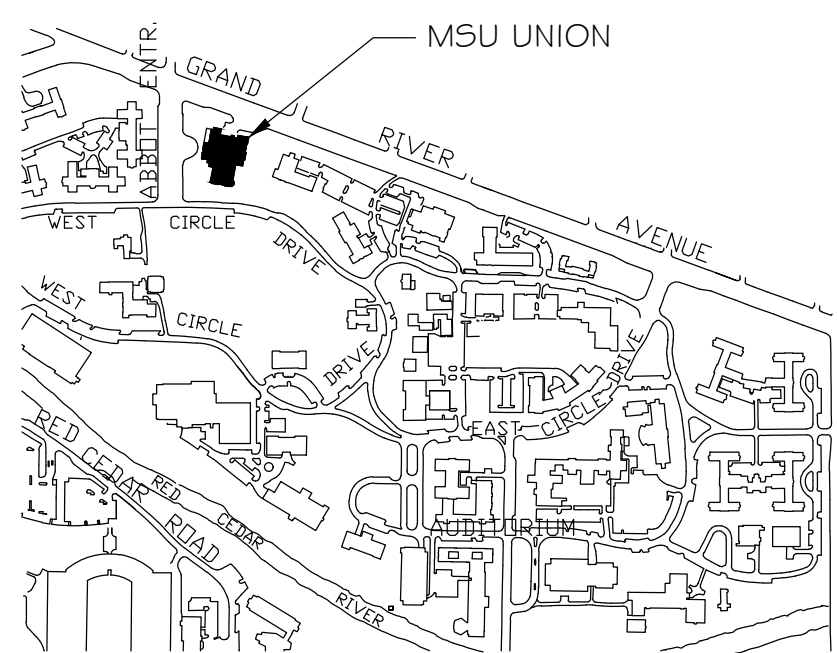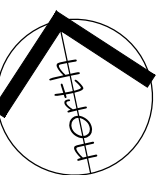

CAMPUS MAP
not to scale

GENERAL NOTES:

- All areas and dimensions shown are approximate and based upon rough field measurements taken by representatives of Roofing Technology Associates, Ltd.
- This drawing should not be used for bidding or estimating purposes. Contractors are responsible for their own field measurements, quantities and verification of conditions shown.


CAPITAL PROJ. NO.
CP22133

PR. MGR.	PACIFICO
ARCH.	CHARLAND
MECH.	
ELEC.	
CIVIL	
L.A.	WILBER
INT. DES.	
CONST. REP.	PACIFICO
APPR.	BONK
DATE	03/05/2025
SCALE	1"=16'
ISSUED	


RELEASE FOR BID

ROOF PLANS
AREAS 8 & 29


1

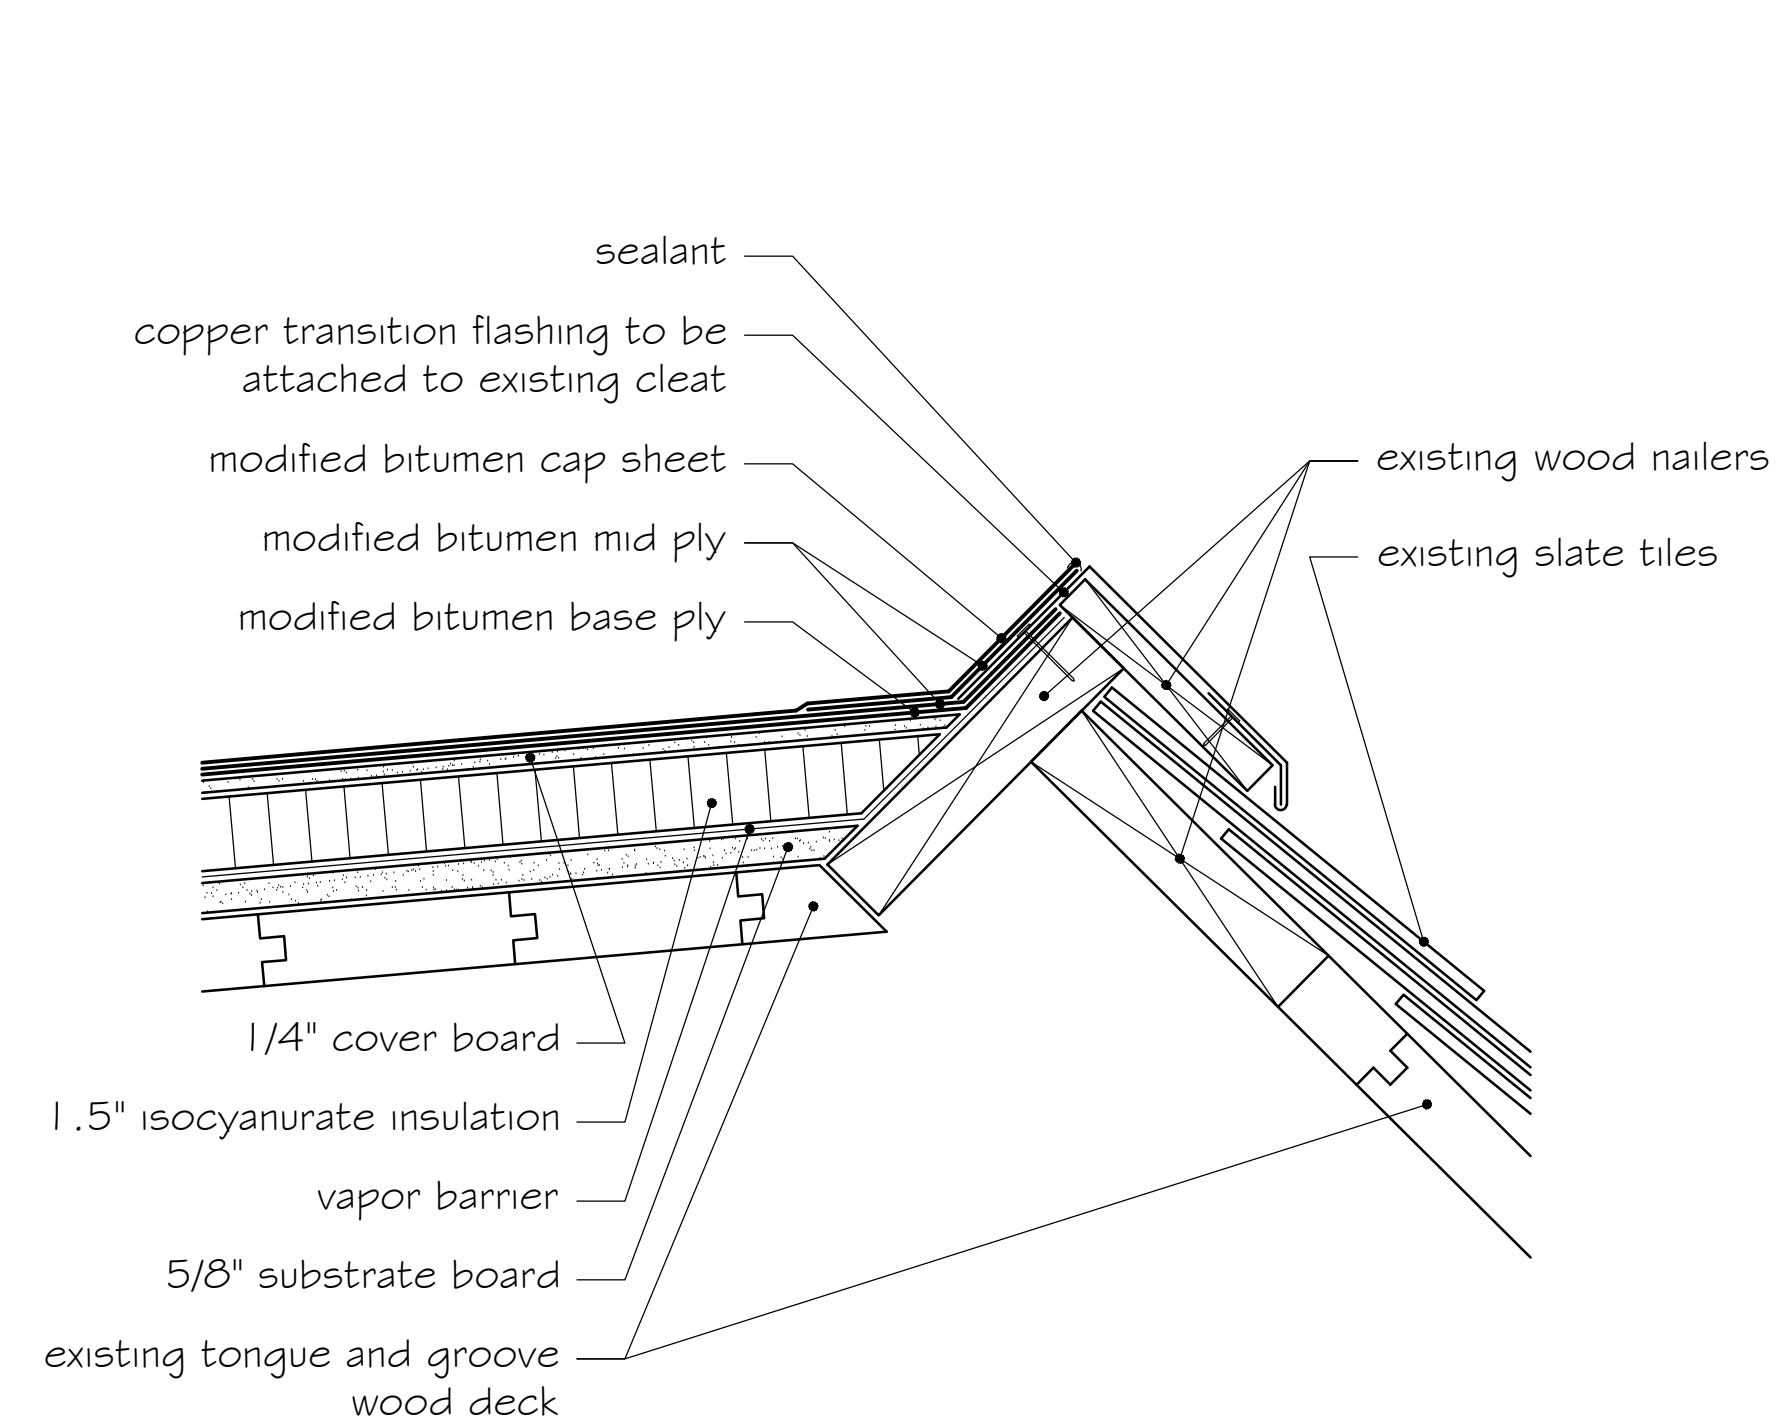


1 PERIMETER EDGE - AREA 29
SCALE: 1" = 4"

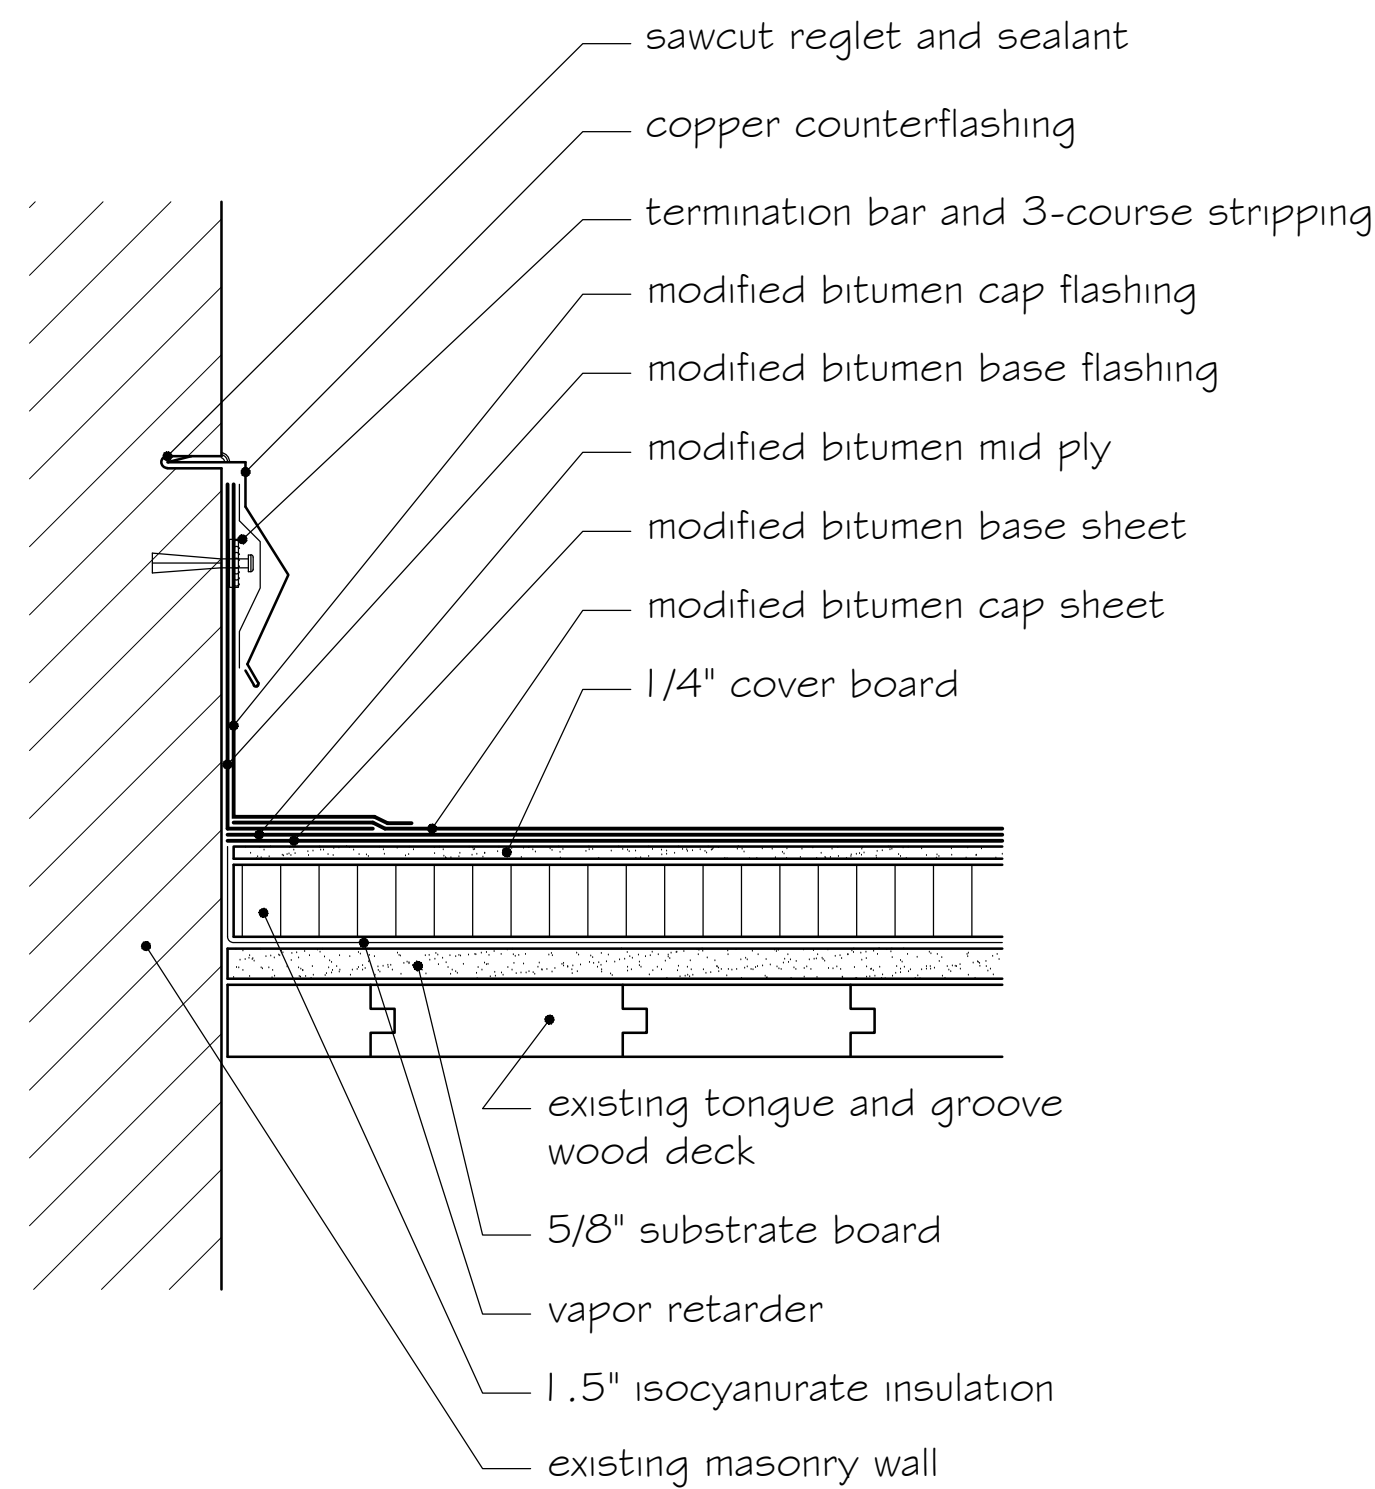


2 REGLET MOUNTED COUNTERFLASHING - AREA 29
SCALE: 1" = 4"

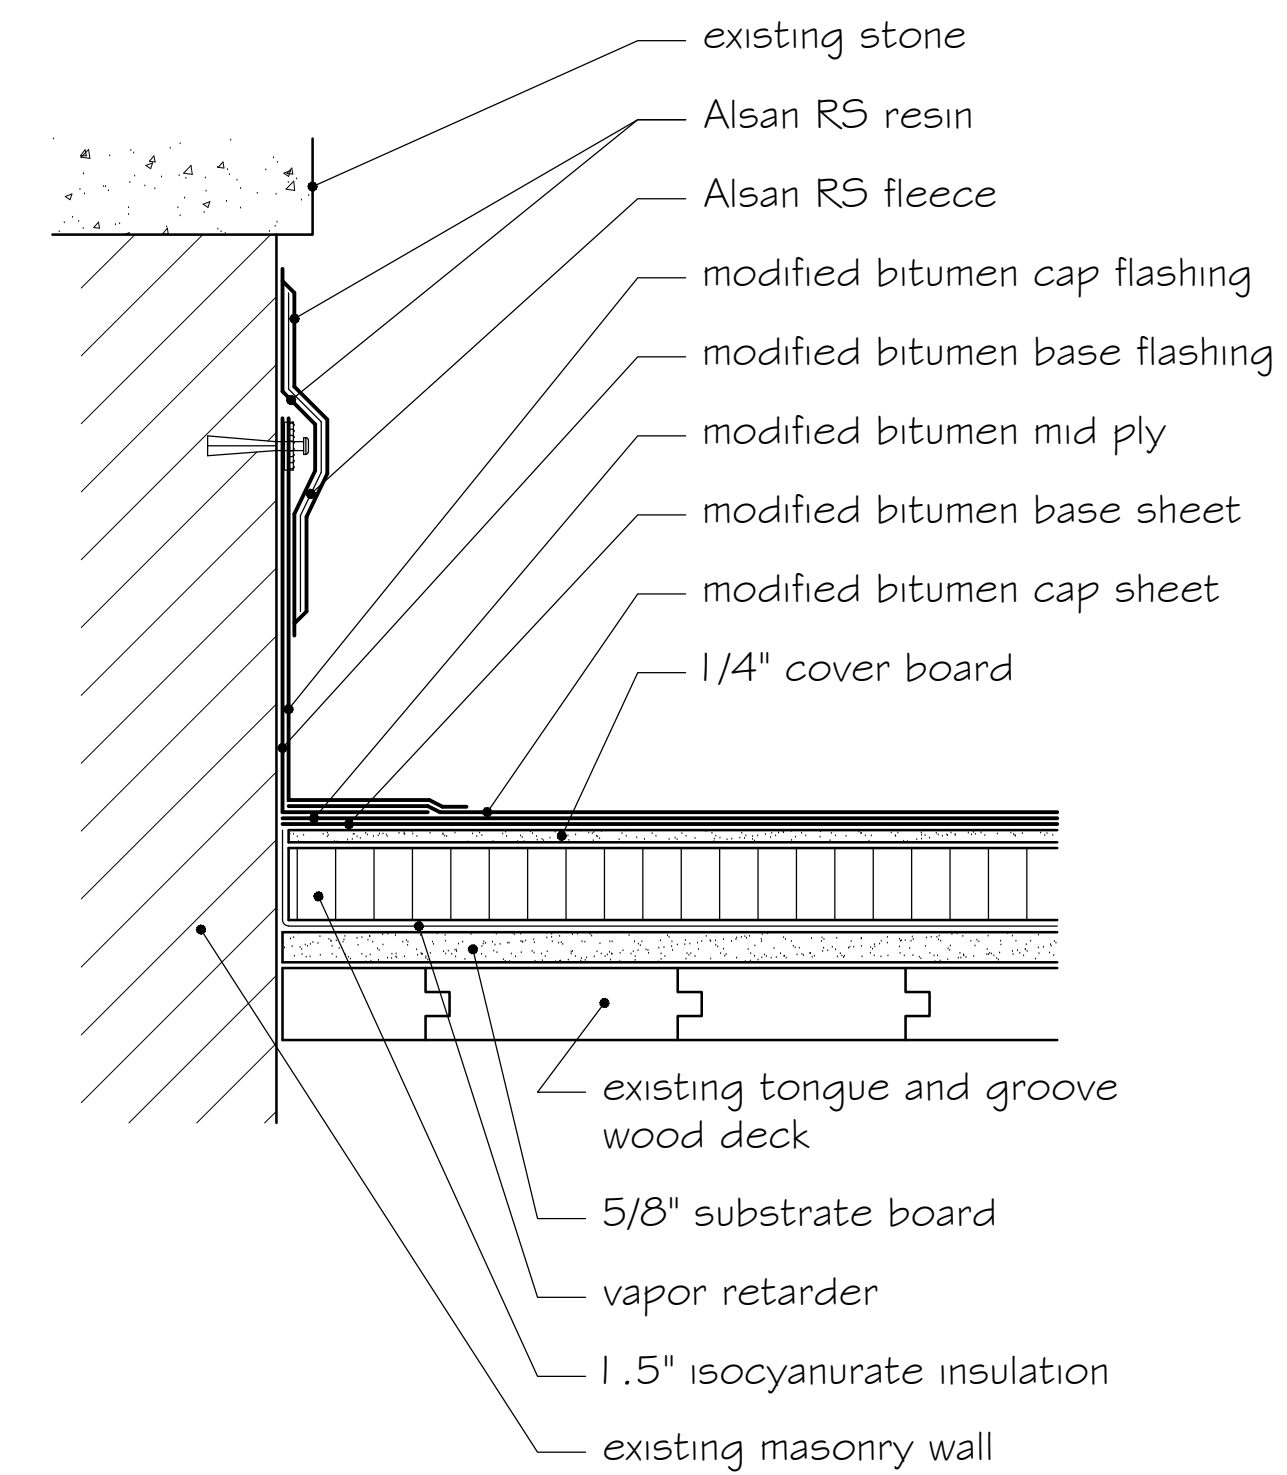


3 LIQUID APPLIED WALL TERMINATION - AREA 29
SCALE: 1" = 4"

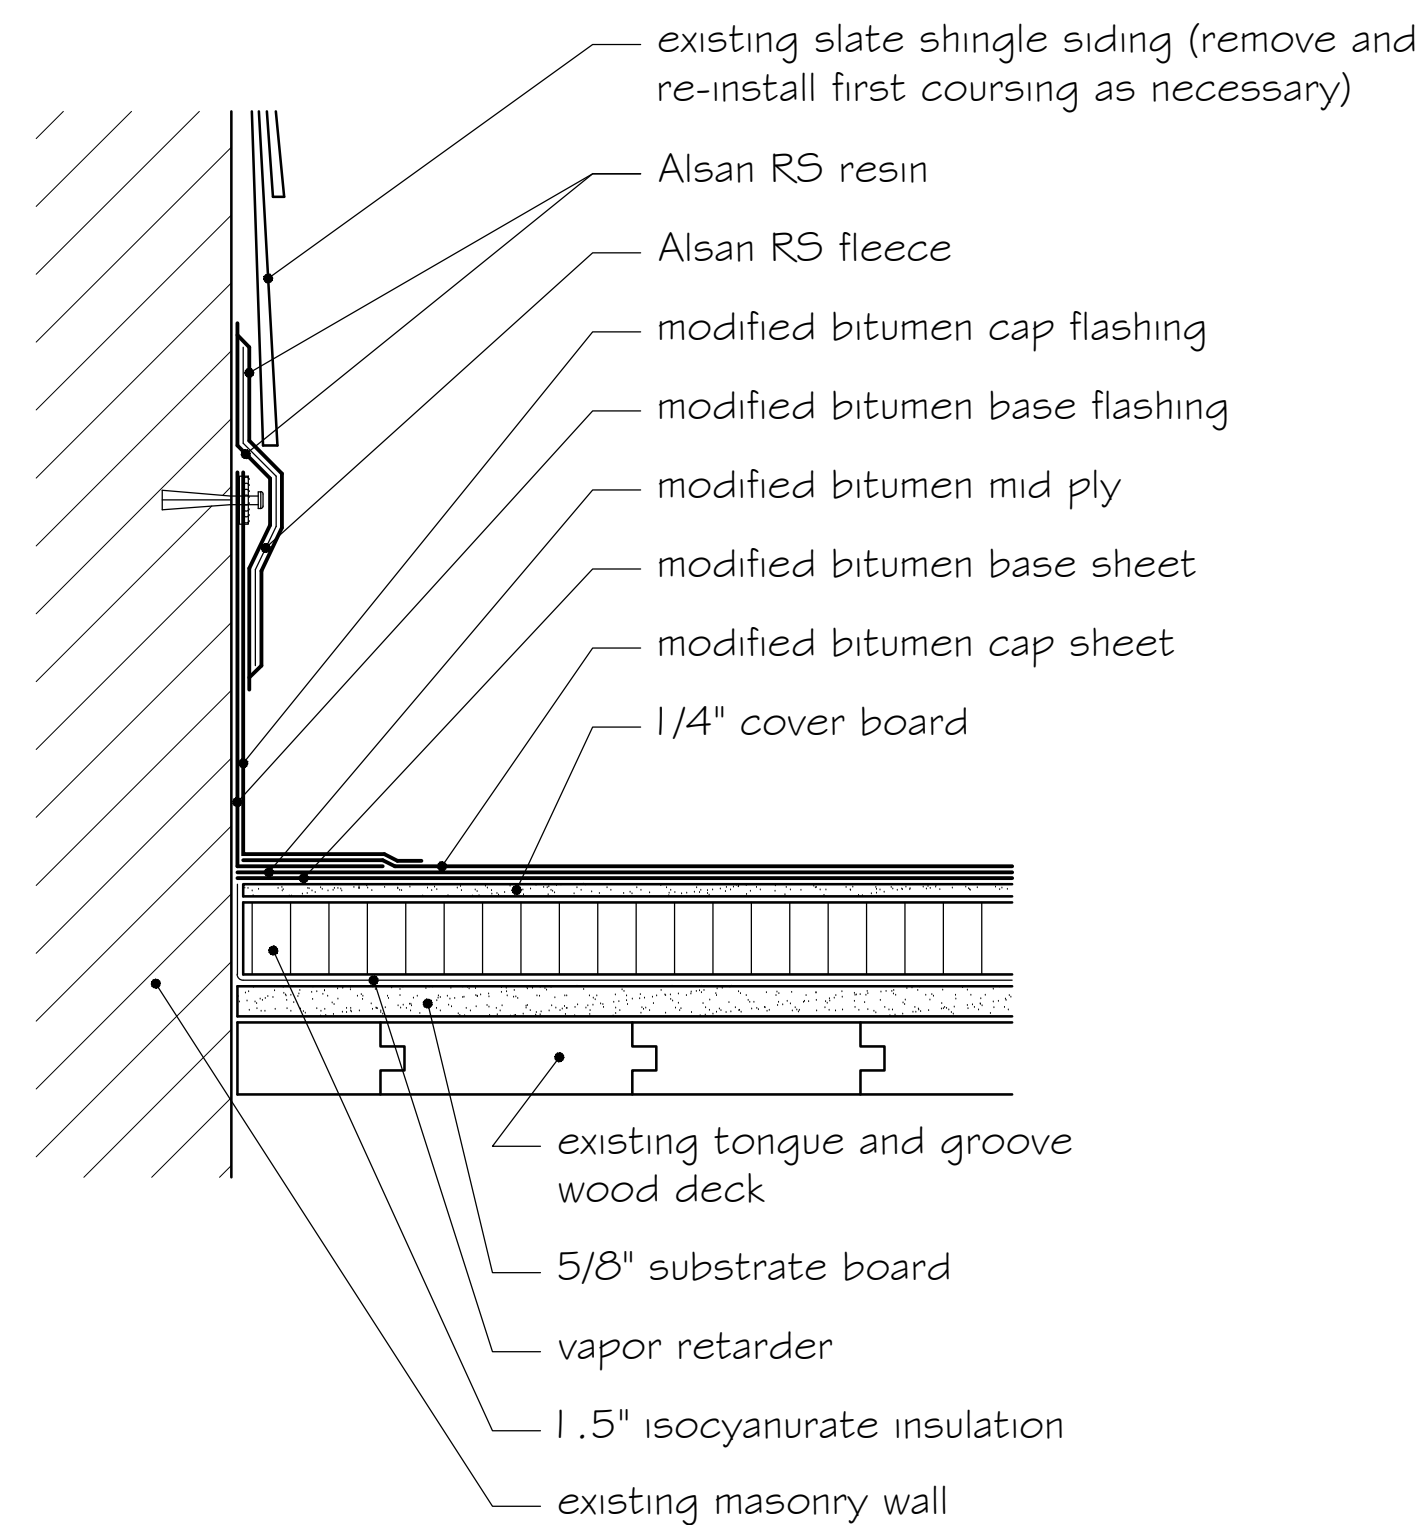

4 ROOF HATCH - AREA 29
SCALE: 1" = 4"

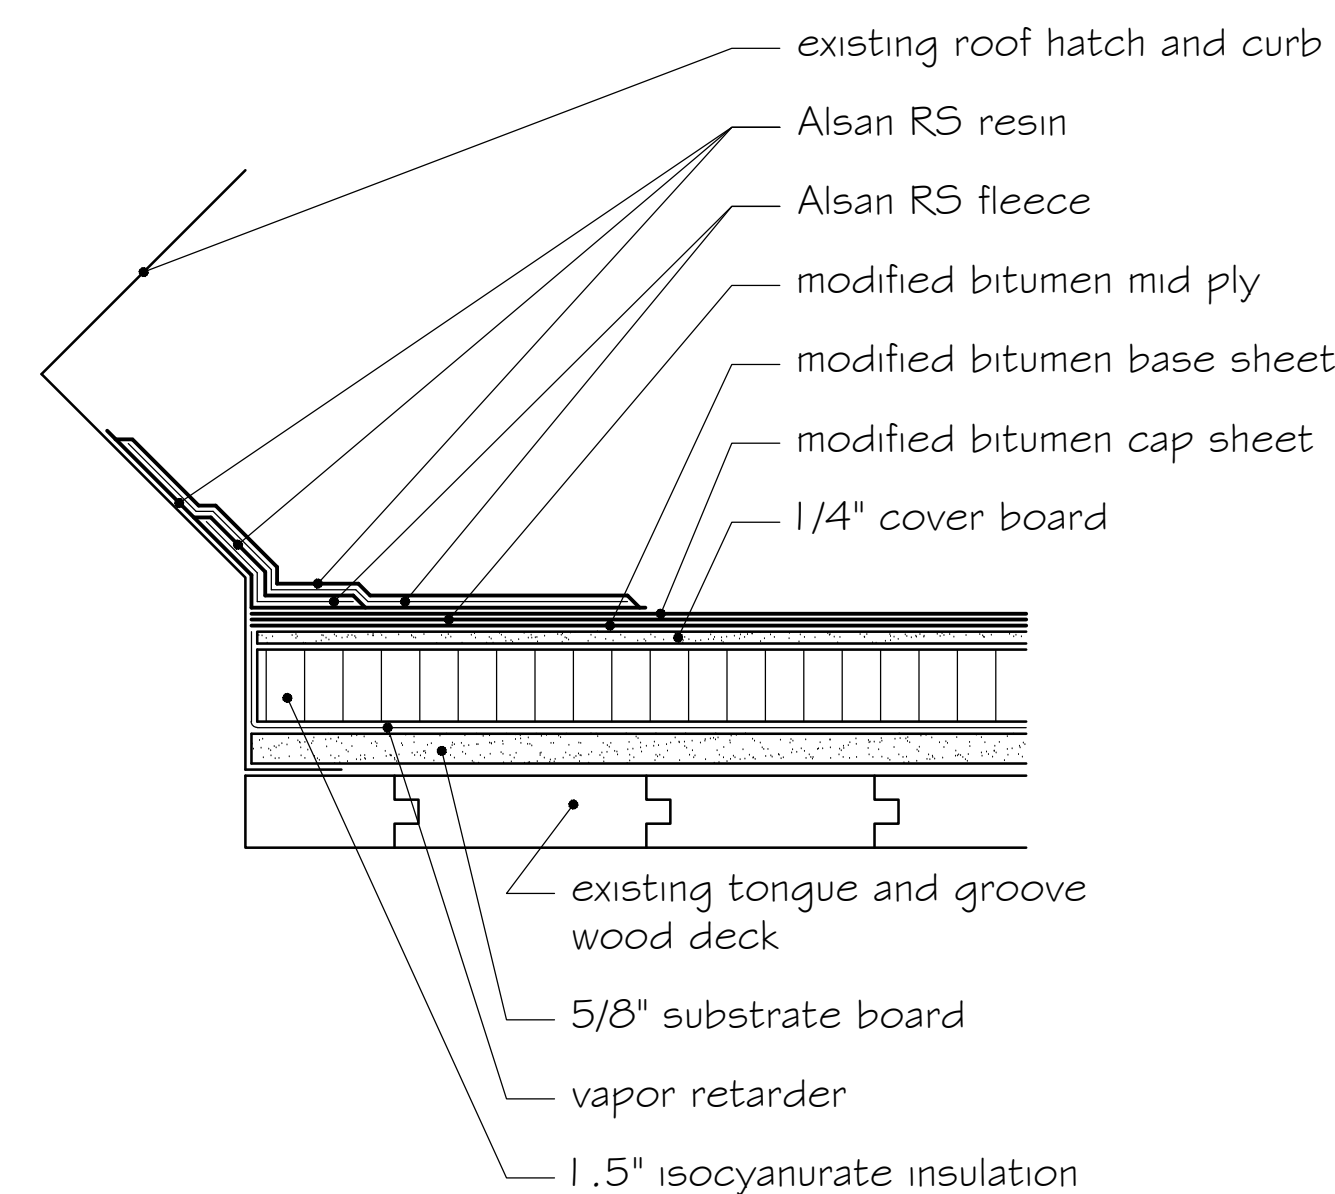

5 ROOF HATCH - AREA 29
SCALE: 1" = 4"

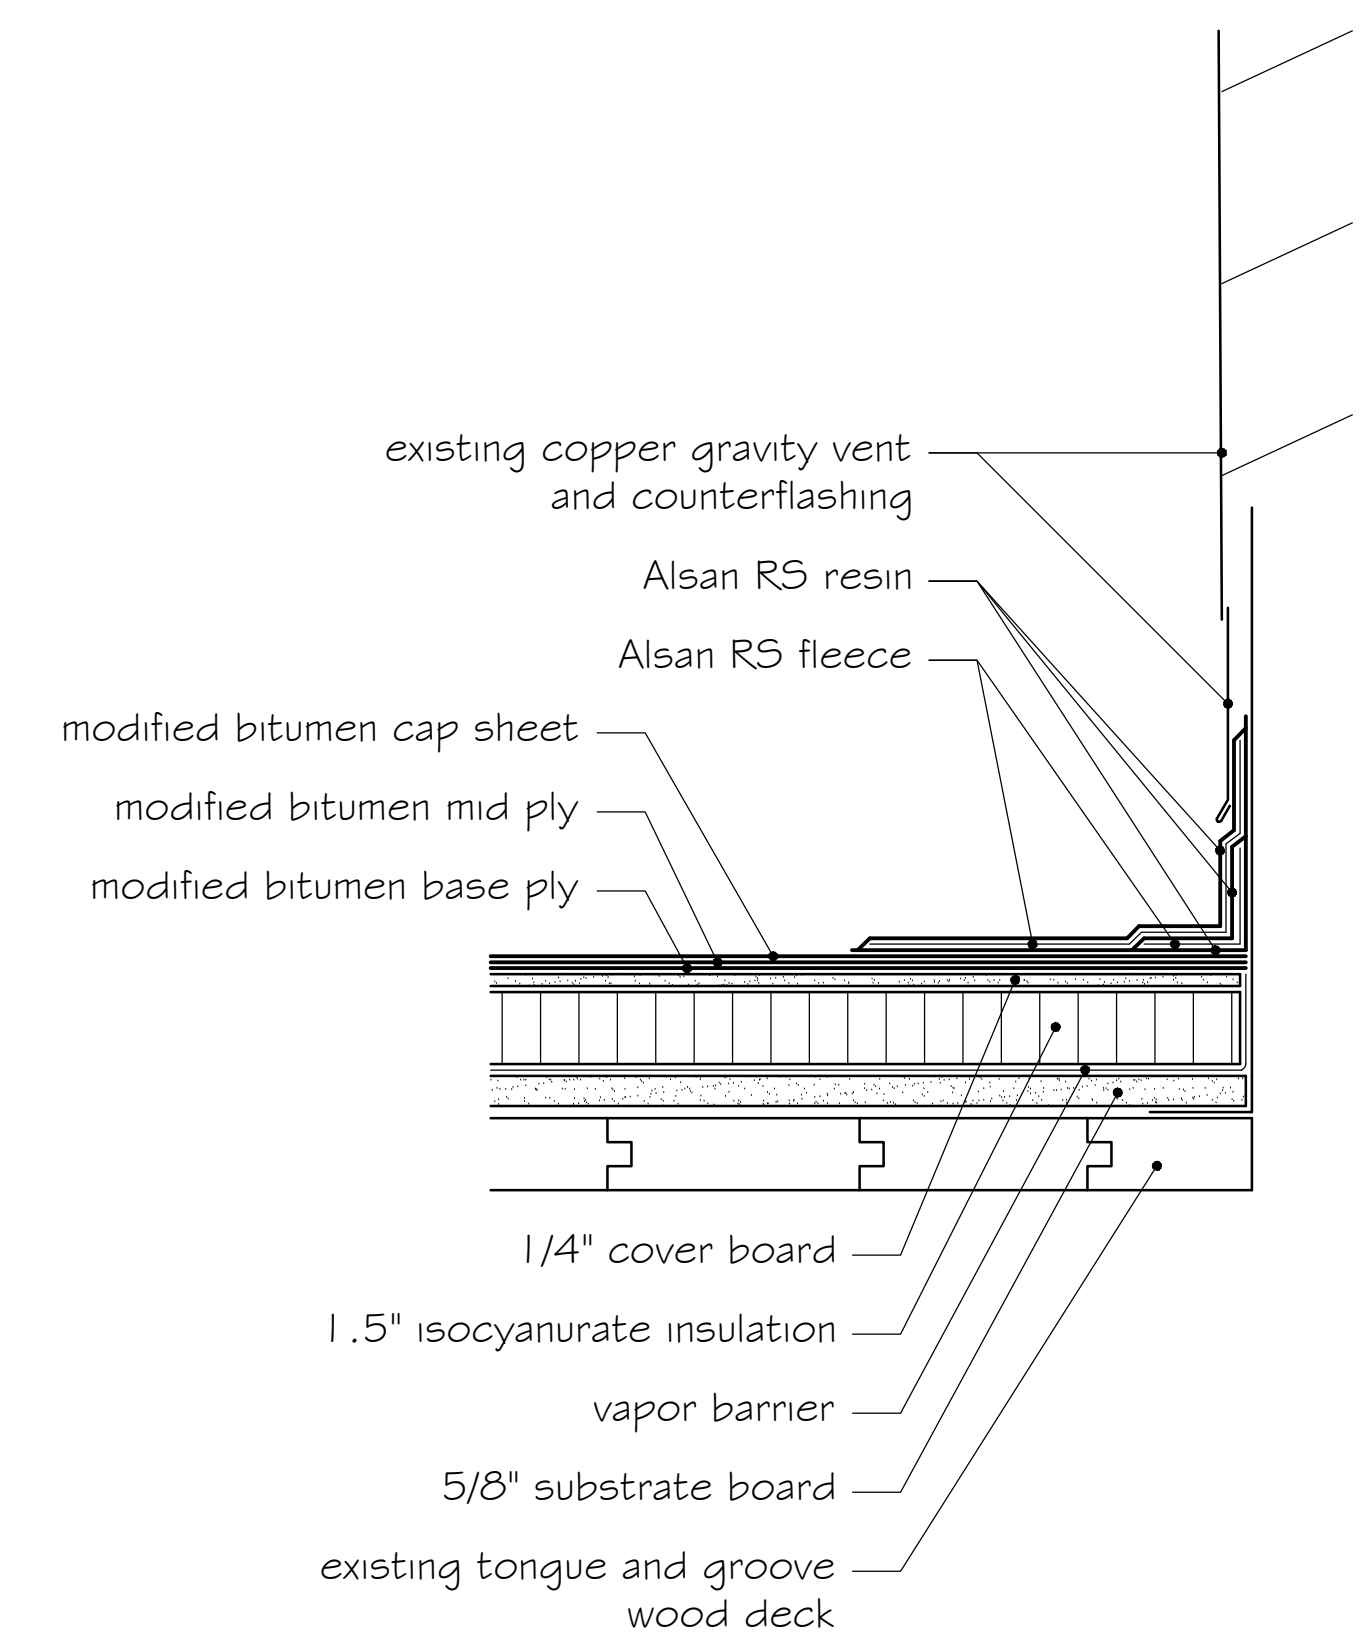


6 GRAVITY VENT FLASHING - AREA 29
SCALE: 1" = 4"

CAPITAL PROJ. NO.
CP22133

PR. MGR.	PACIFICO
ARCH.	CHARLAND
MECH.	
ELEC.	
CIVIL	
L.A.	WILBER
INT. DES.	
CONST. REP.	PACIFICO
APPR.	BONK
DATE	03/05/2025
SCALE	AS NOTED
ISSUED	


RELEASE FOR BID

ROOFING DETAILS

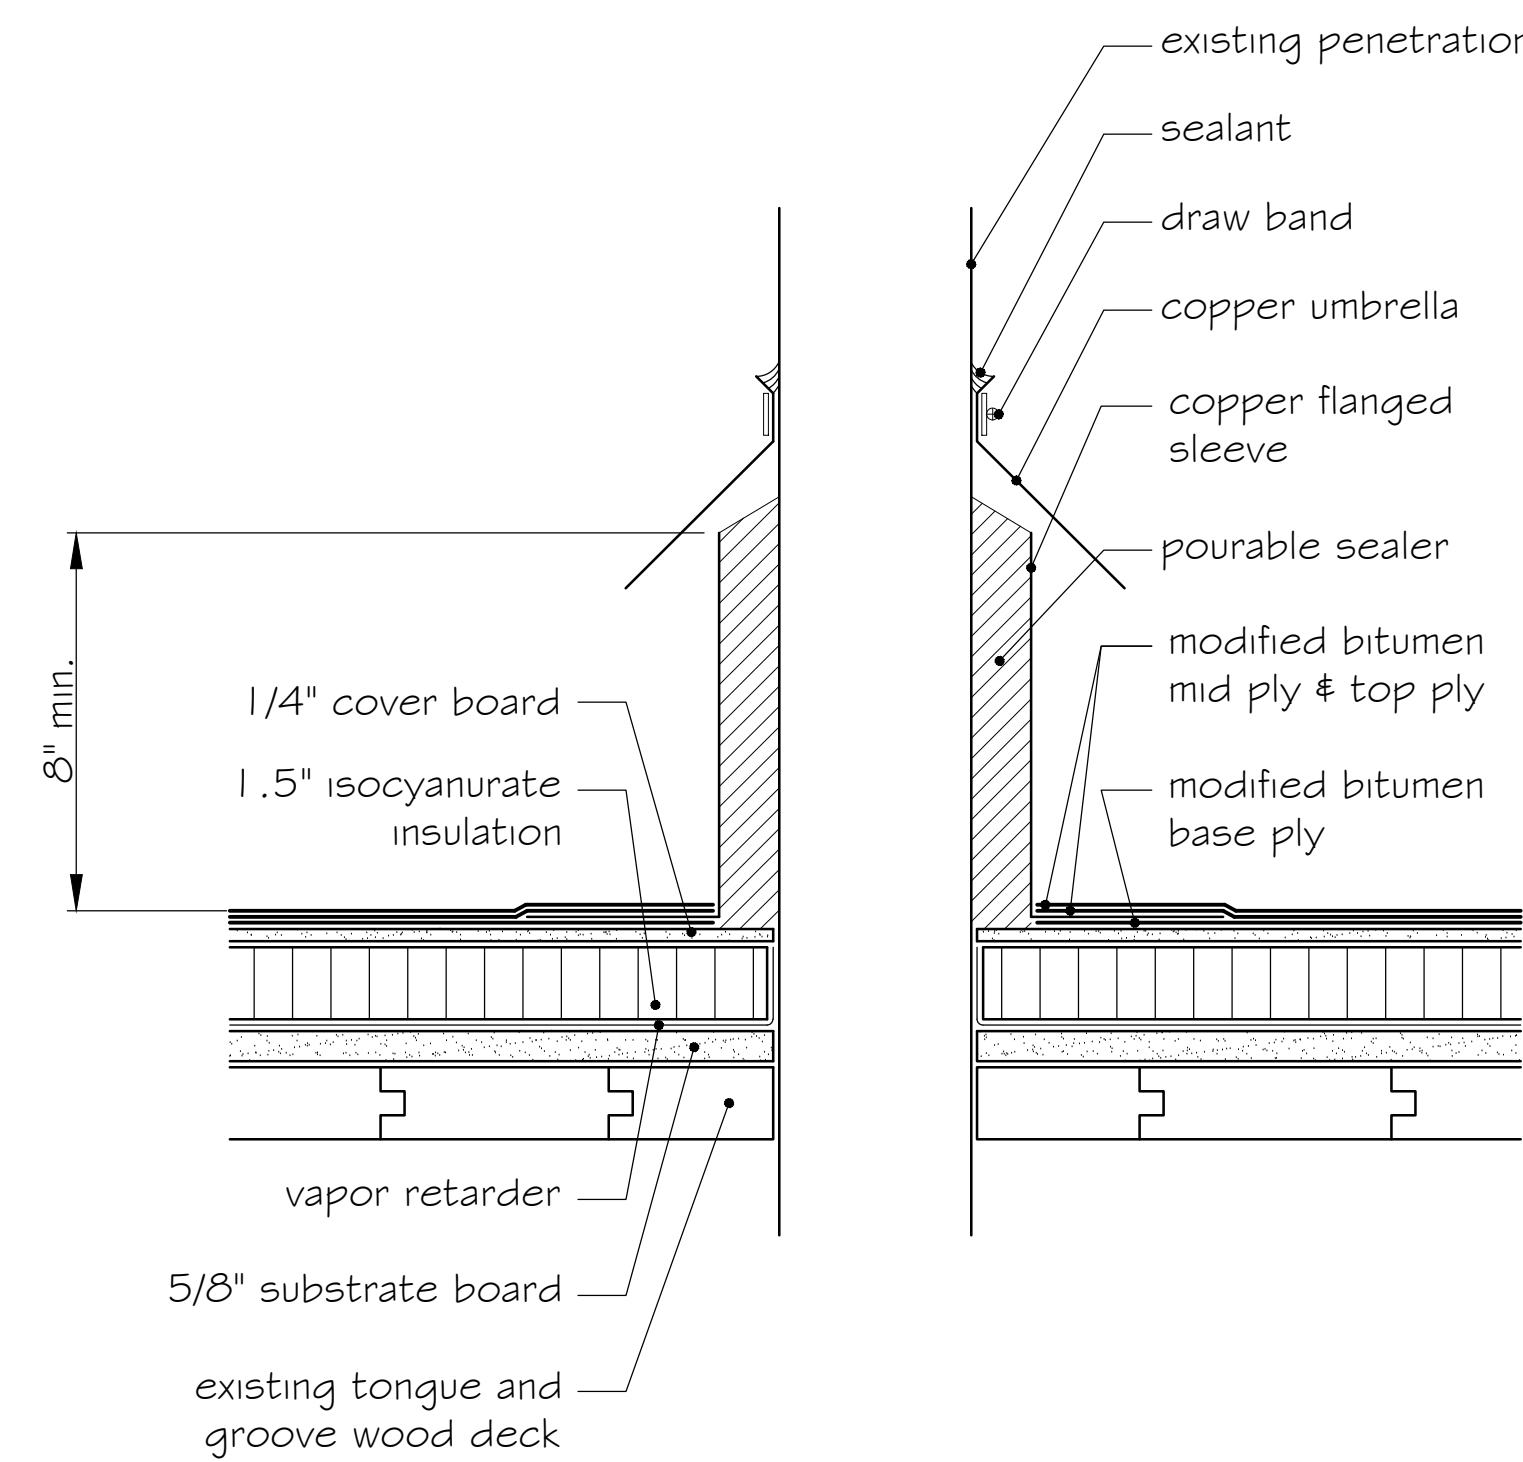


7 PLUMBING VENT PIPE FLASHING - AREA 29

SCALE: 1" = 4"

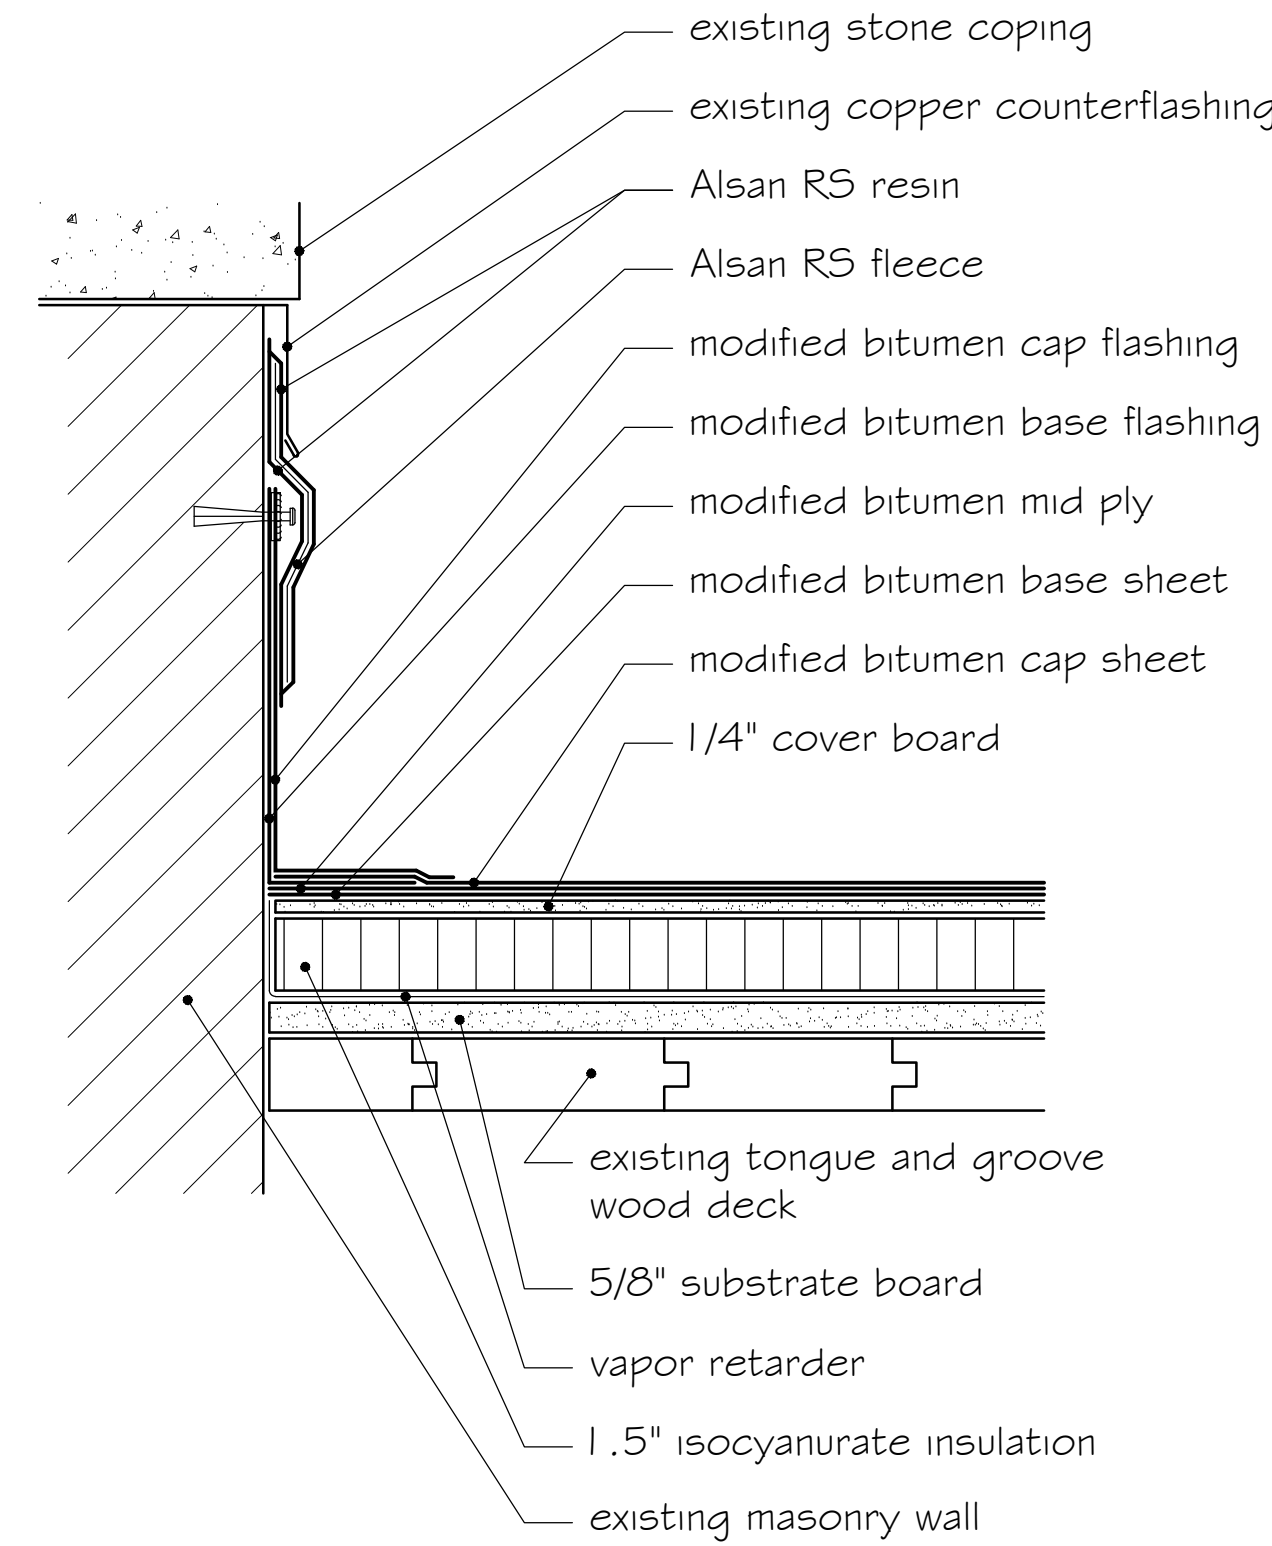


8 WALL FLASHING - AREA 29

SCALE: 1" = 4"

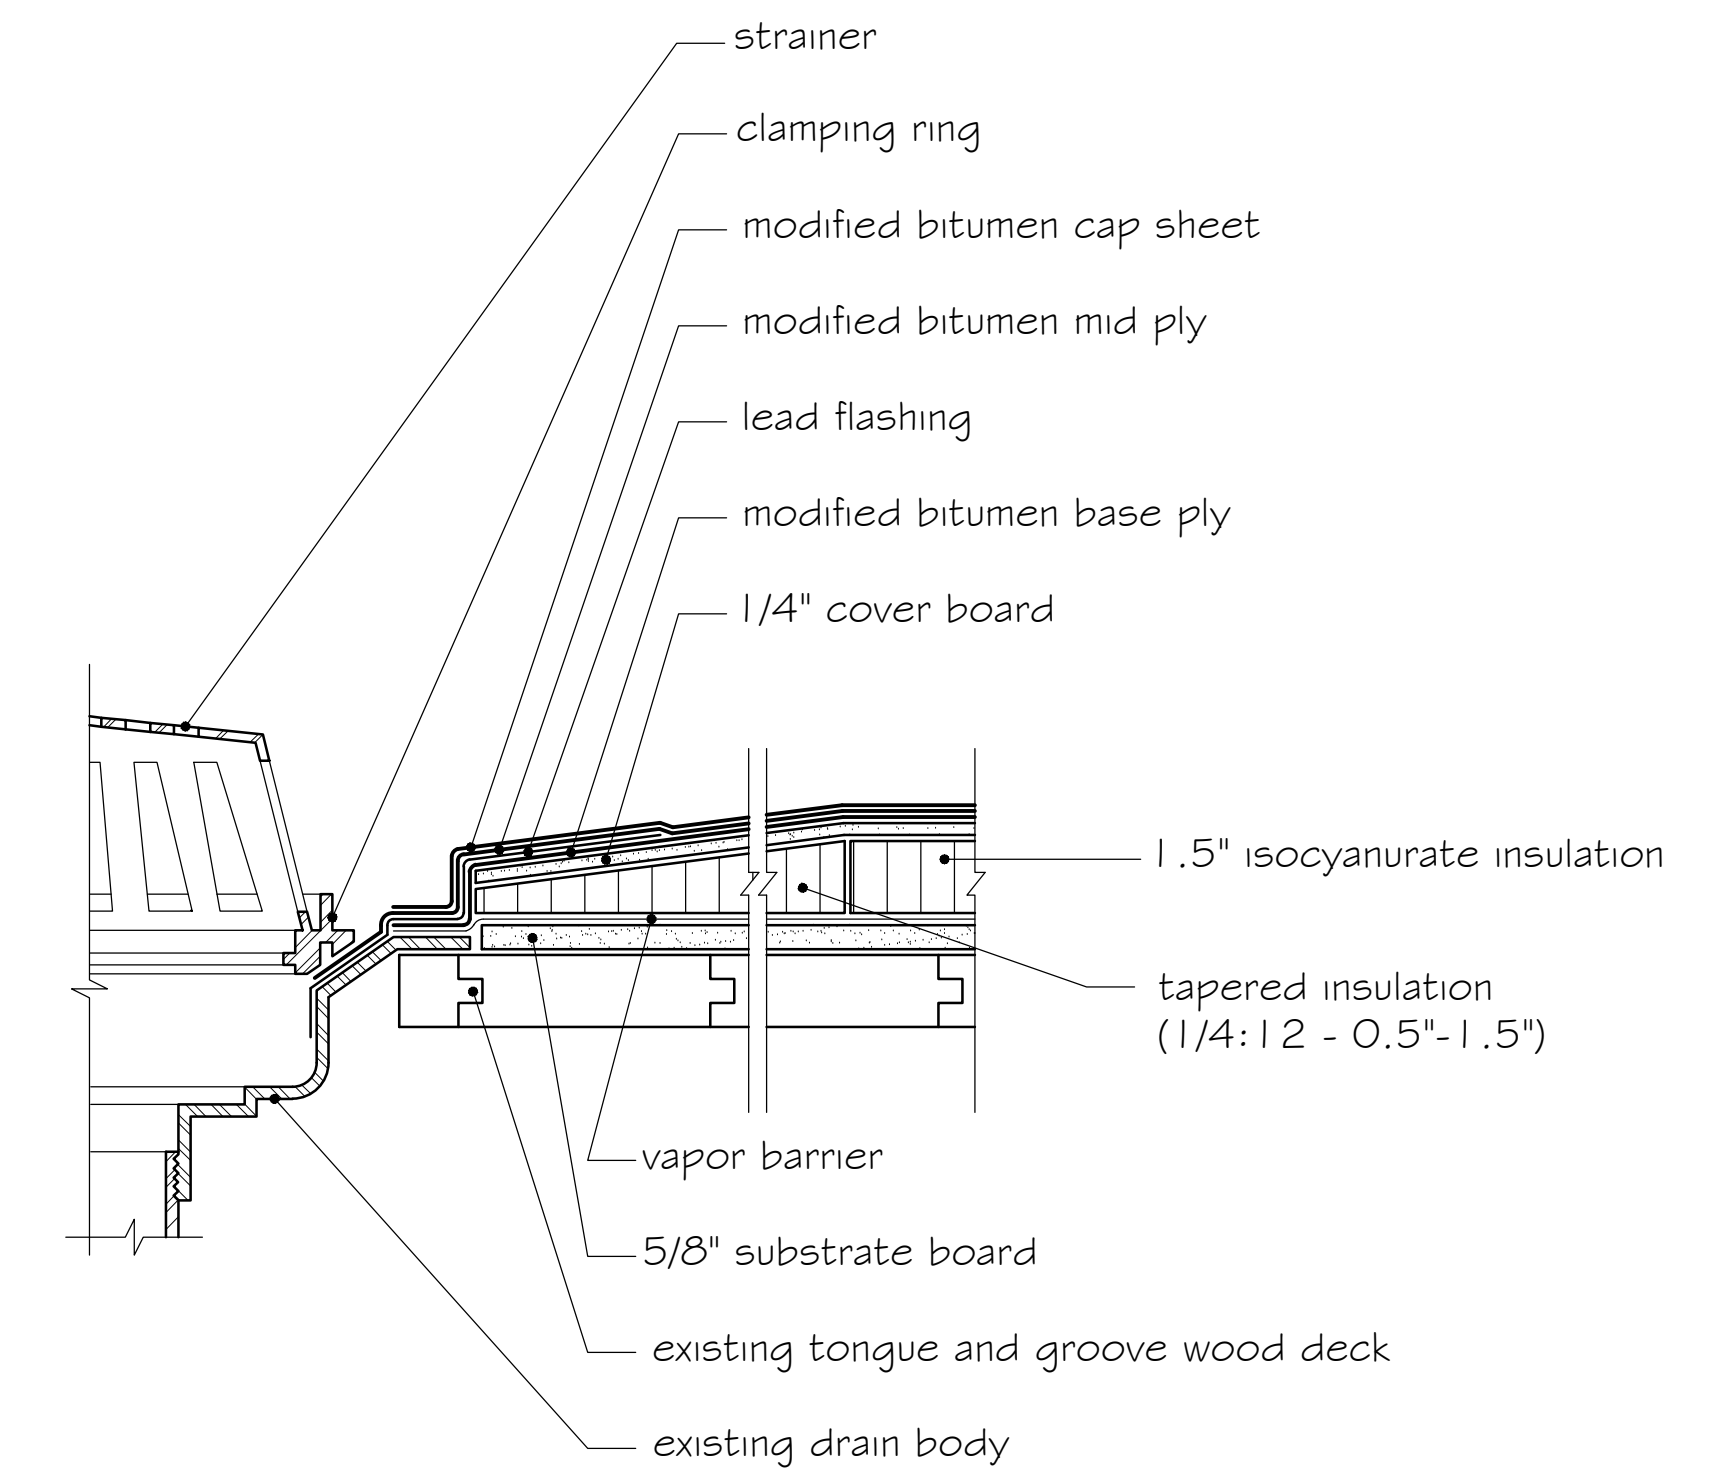


9 ROOF DRAIN - AREA 29

SCALE: 1" = 4"

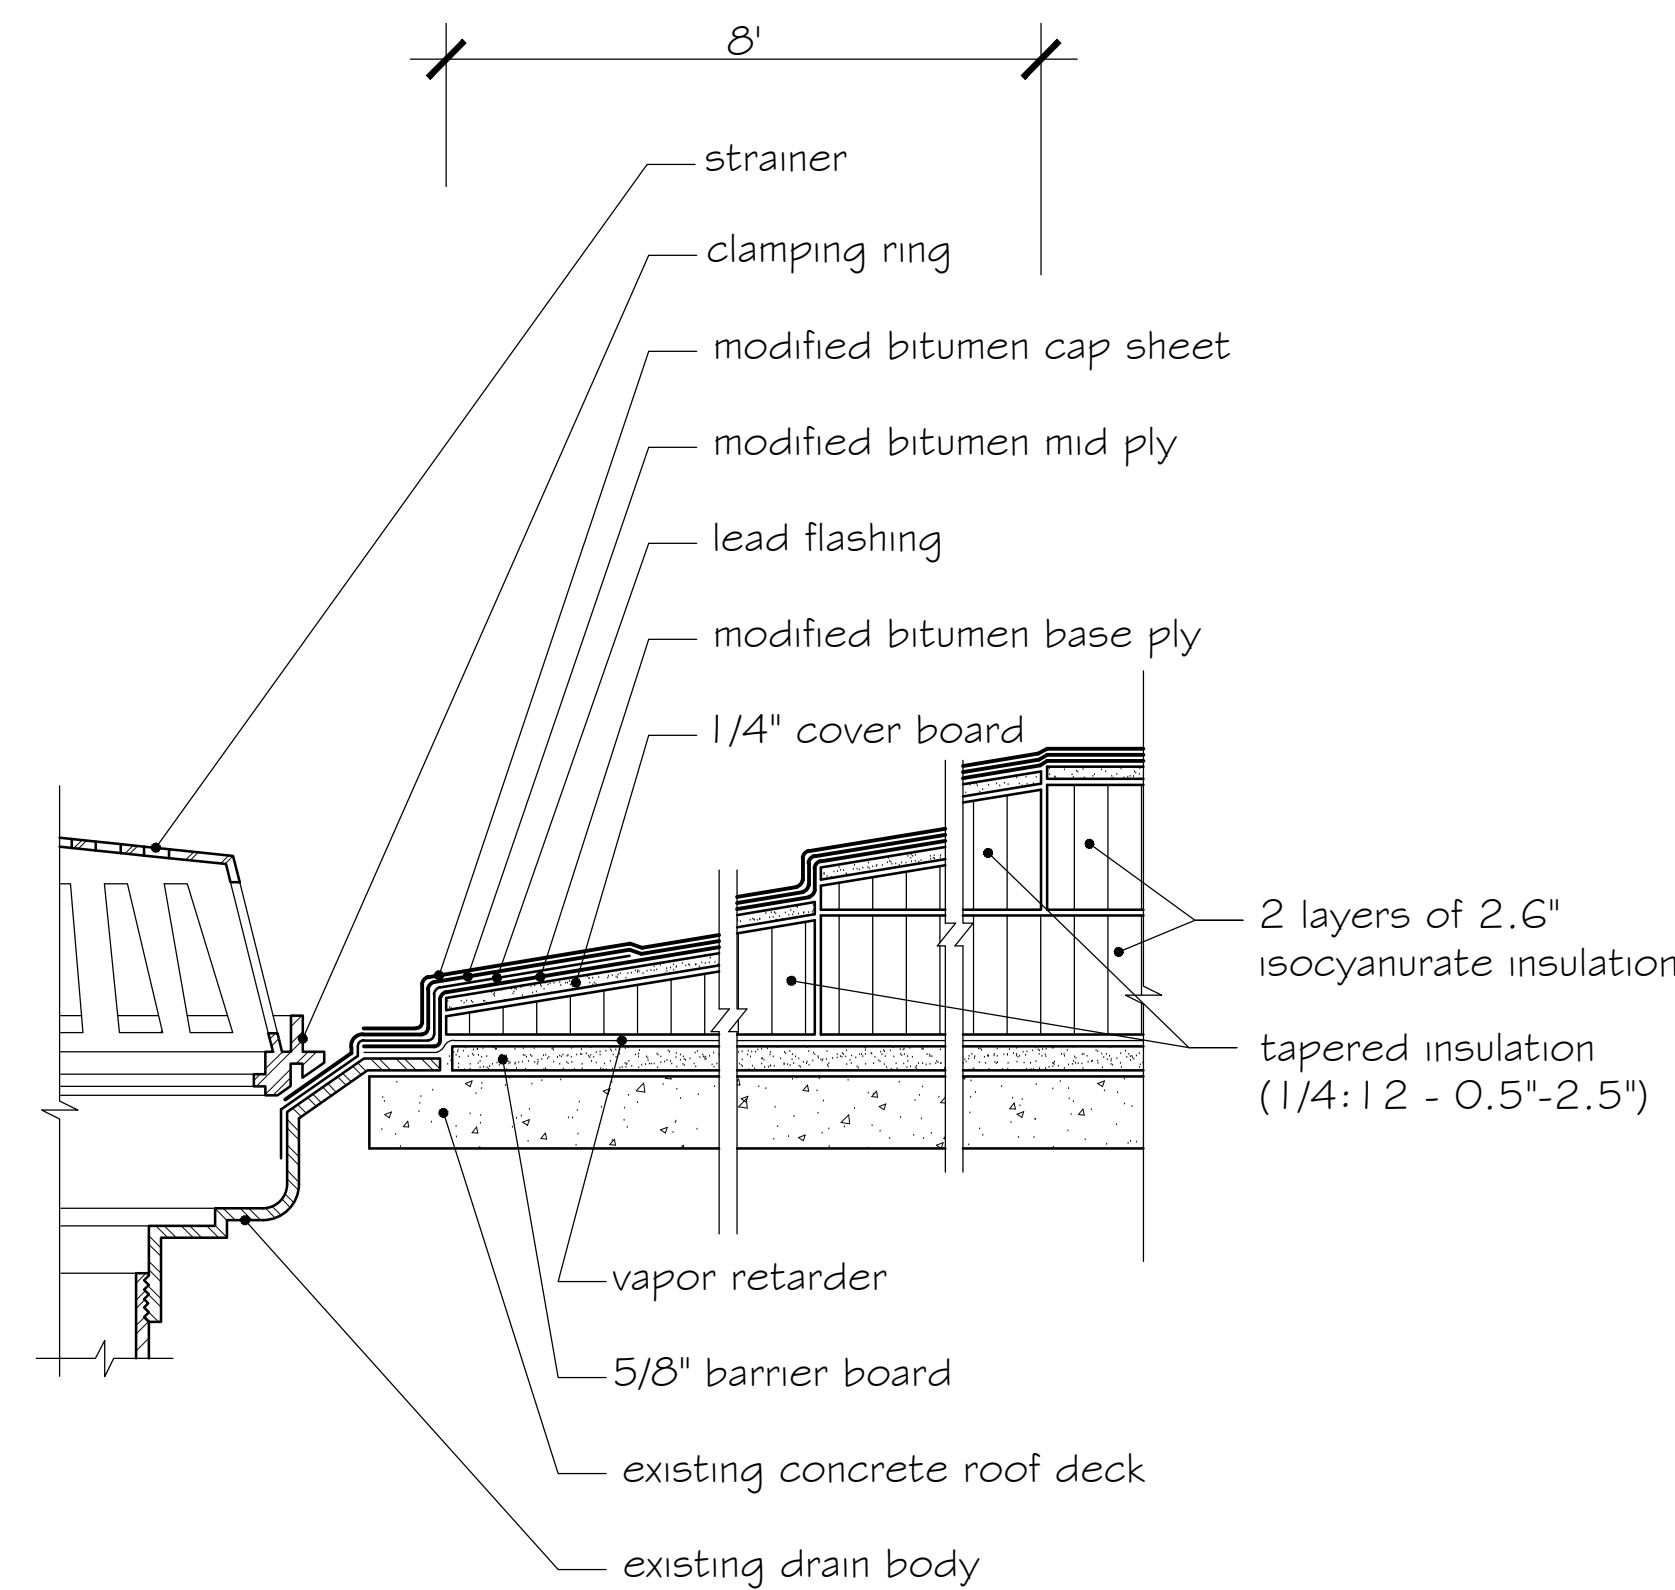


10 ROOF DRAIN - AREA 8

SCALE: 1" = 4"

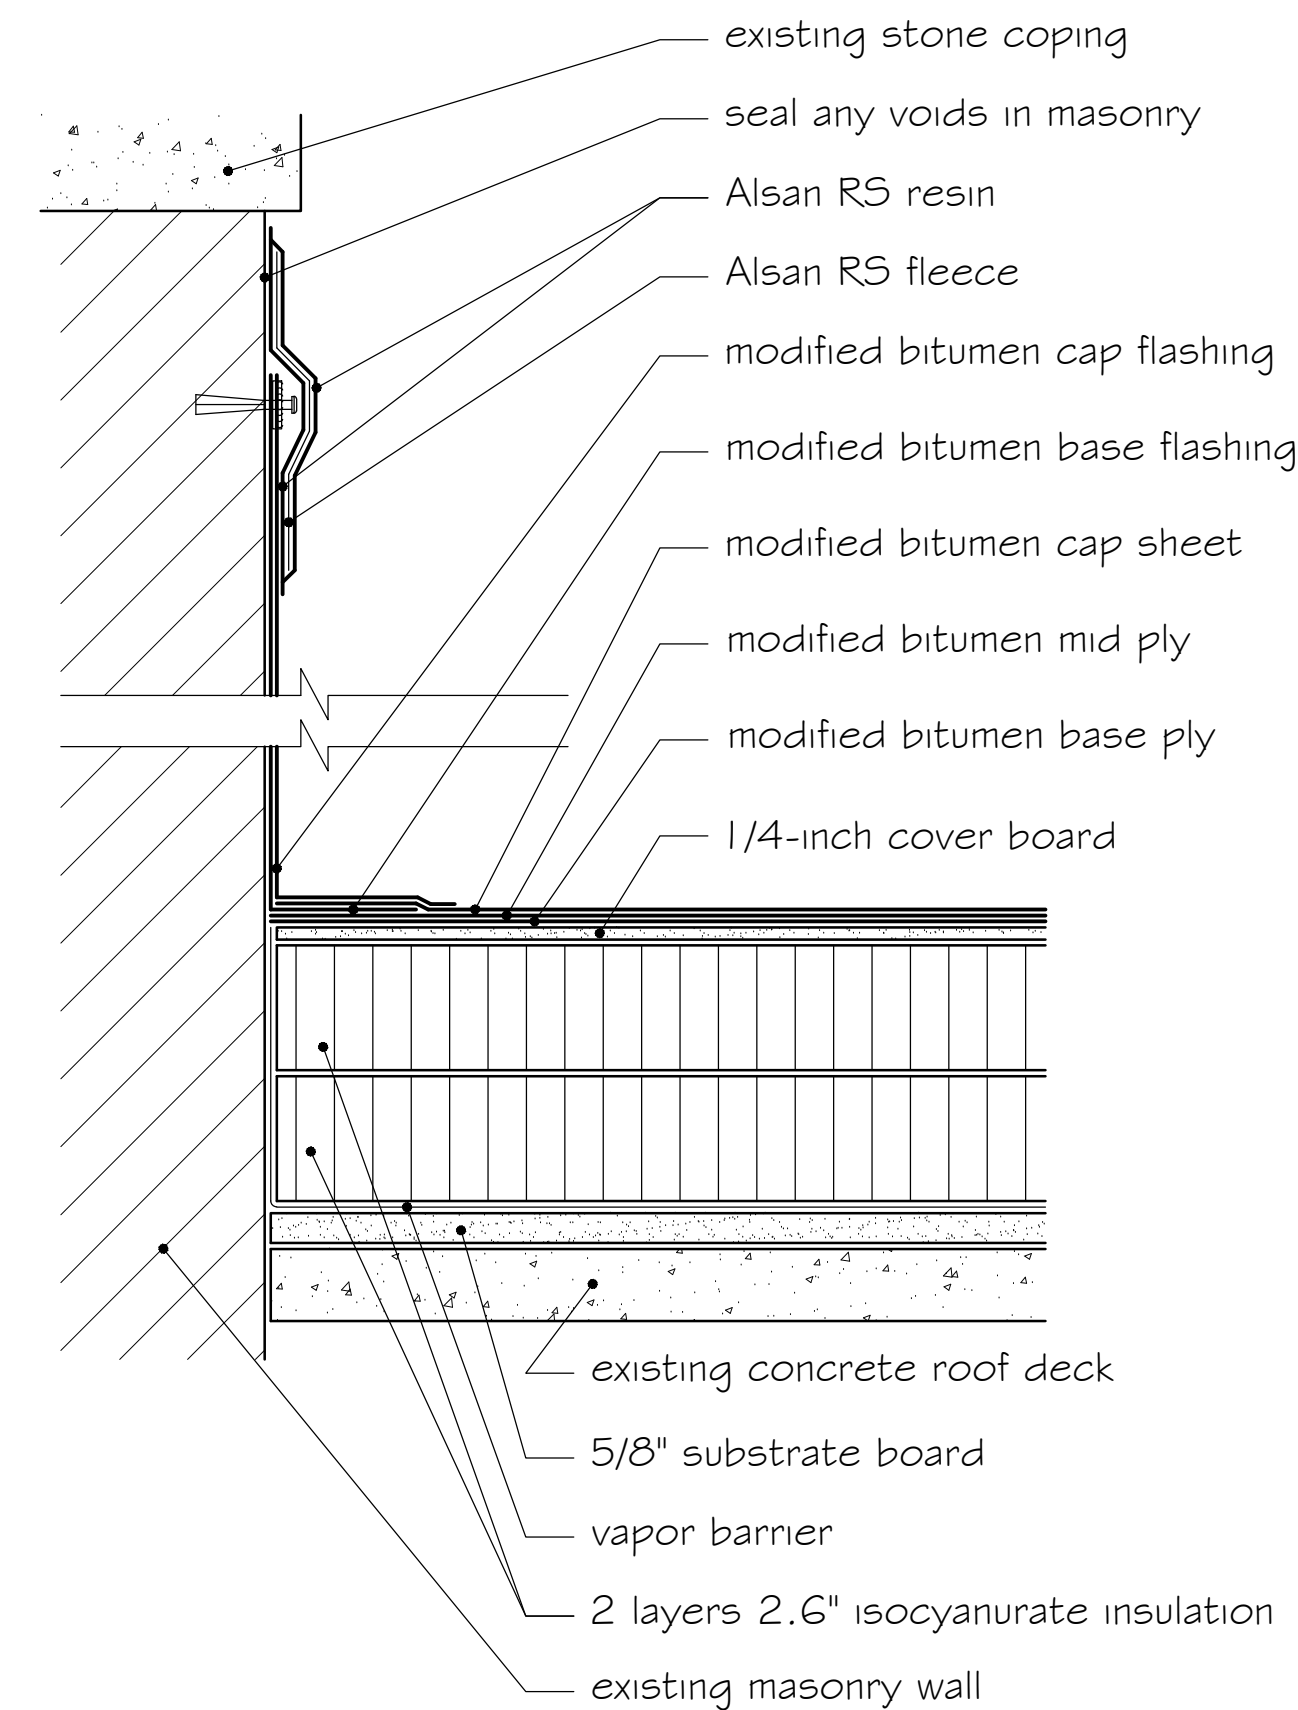

11 WALL FLASHING - AREA 8

SCALE: 1" = 4"

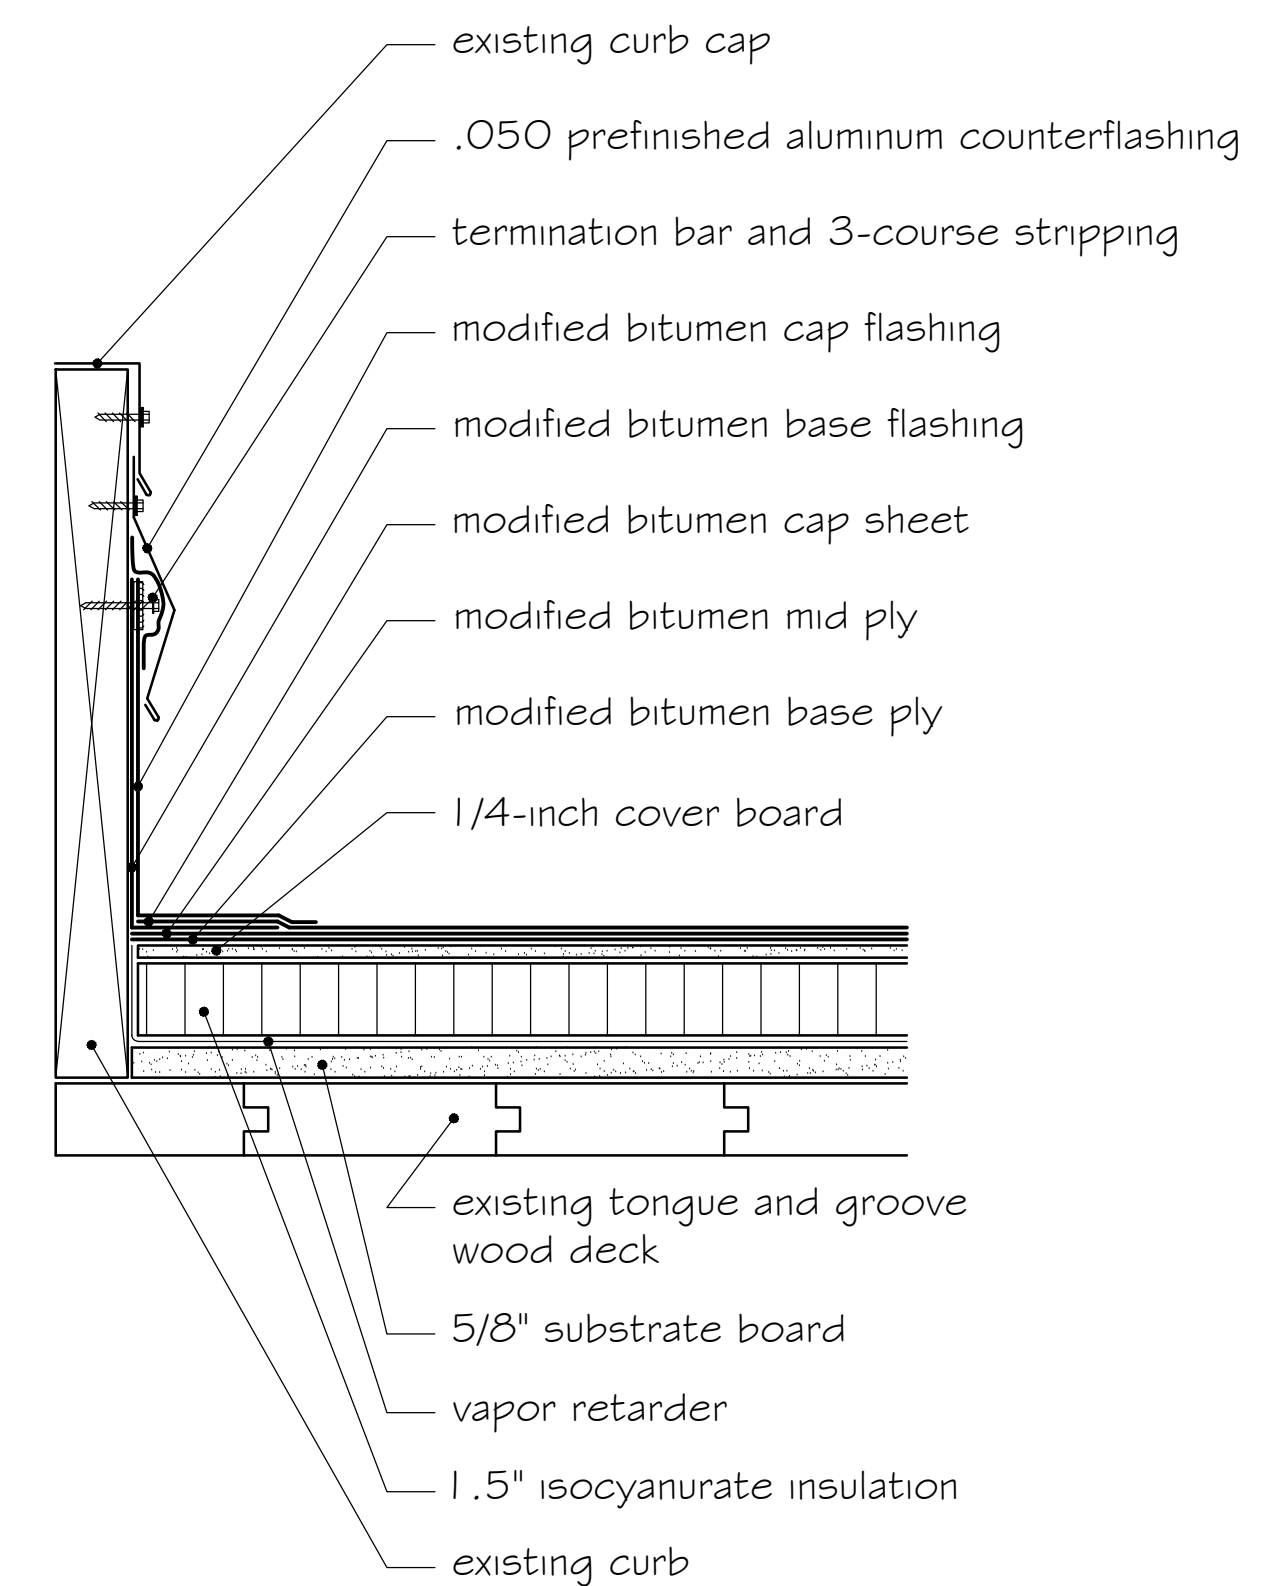

12 CURB FLASHING - AREA 29

SCALE: 1" = 4"

CAPITAL PROJ. NO.
CP22133

PR. MGR.	PACIFICO
ARCH.	CHARLAND
MECH.	
ELEC.	
CIVIL	
L.A.	WILBER
INT. DES.	
CONST. REP.	PACIFICO
APPR.	BONK
DATE	03/05/2025
SCALE	AS NOTED
ISSUED	

RELEASE FOR BID

ROOFING DETAILS